



GENERAL NOTES

DO NOT SCALE DRAWINGS
 ANY MISSING OR UNCLEAR DIMENSIONS TO BE REPORTED TO CTX FOR CLARIFICATION
 REFER TO STRUCTURAL ENGINEER NOTES FOR ALL DRAWINGS
 REFER TO MECHANICAL ENGINEERING PLANS FOR PLUMBING AND AIR CONDITIONING SYSTEMS INFORMATION
 REFER TO ELECTRICAL ENGINEERING DRAWINGS FOR ELECTRICAL LAYOUT AND SYSTEM INFORMATION

MAR 6 2012

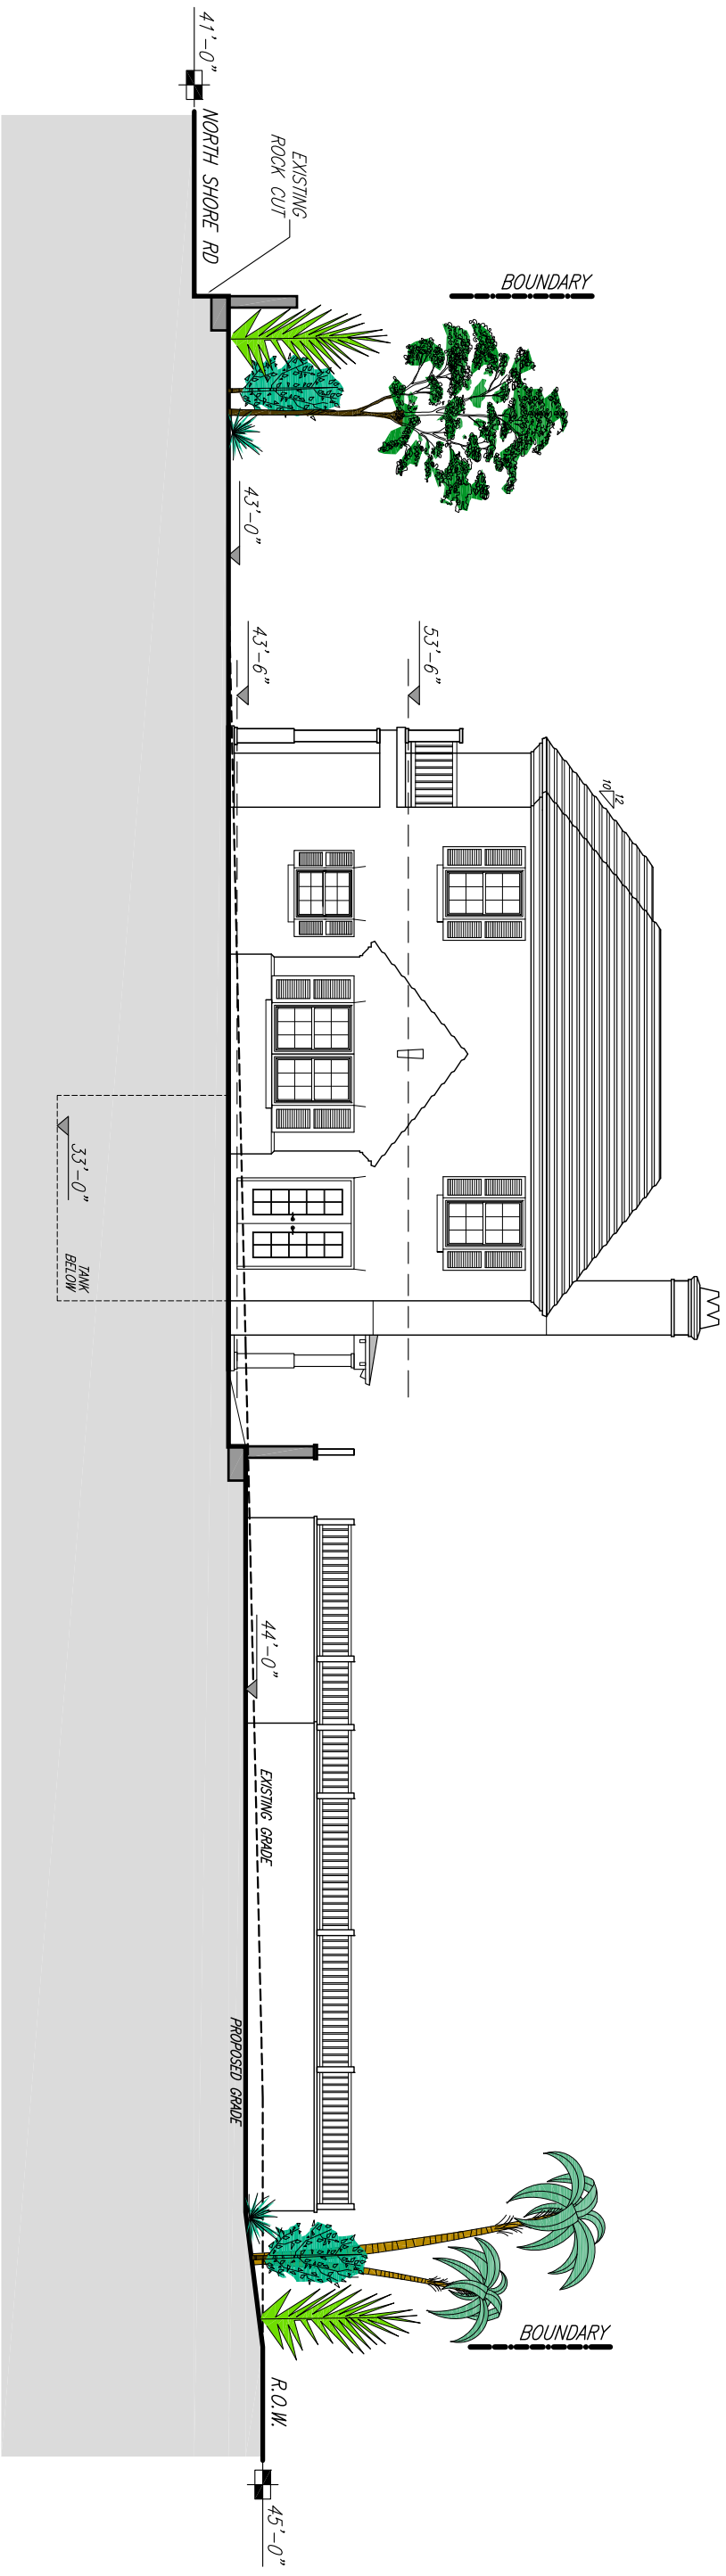

1
 1/4" = 1'-0"
 1/8" INCH SCALE
 2/8" INCH SCALE

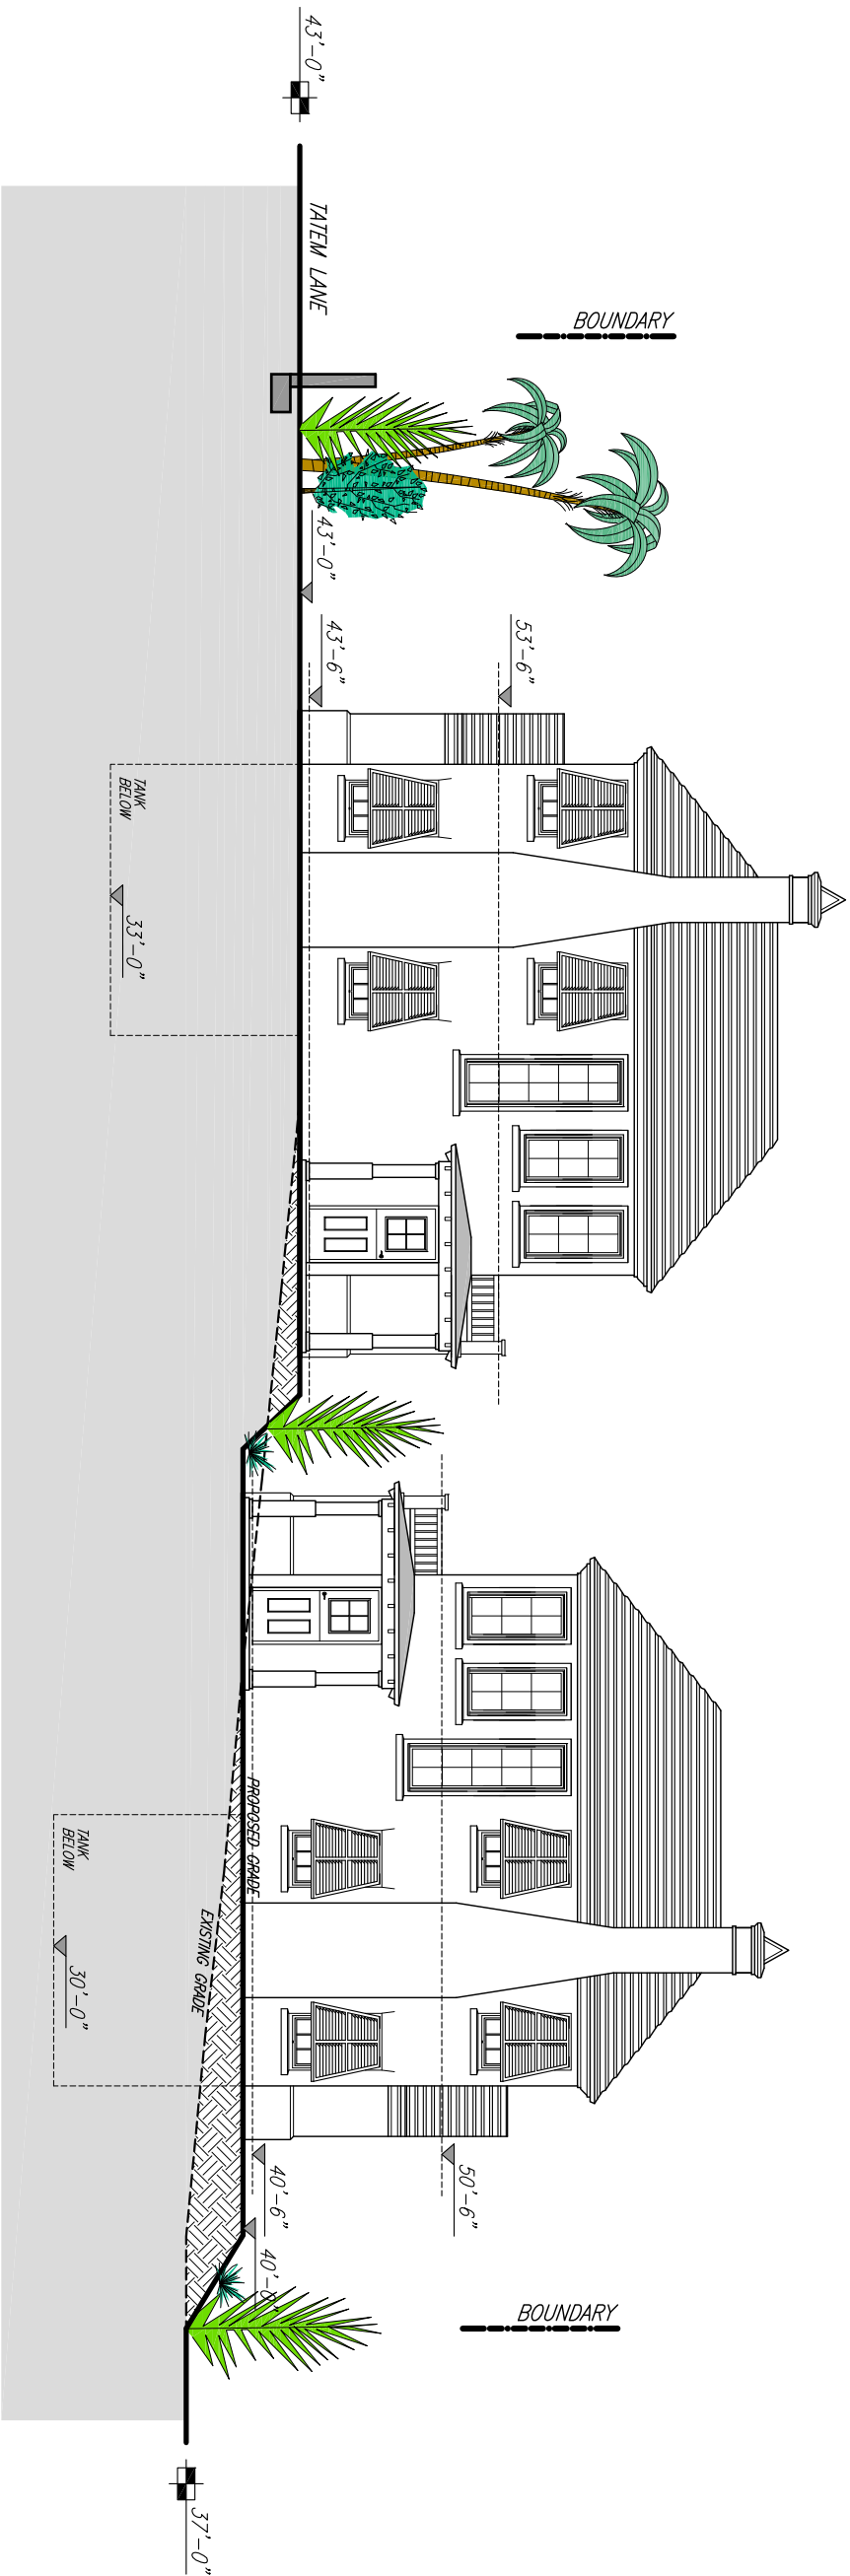

2
 1/4" = 1'-0"
 1/8" INCH SCALE
 2/8" INCH SCALE

REVISIONS

N/A
HIDEAWAY TRUST
LOT 16 & 17 TATEM LN
BERMBOKE PARISH
BERMUDA

ISSUED BY: AAM / SV
 DATE: DEC 2011
 SCALE: AS NOTED