

GENERAL NOTES


DO NOT SCALE DRAWINGS
 ANY MISSING OR UNCLEAR DIMENSIONS TO BE REPORTED TO CTX FOR CLARIFICATION
 REFER TO STRUCTURAL ENGINEER NOTES FOR ALL DRAWINGS
 REFER TO MECHANICAL ENGINEERING PLANS FOR PLUMBING AND AIR CONDITIONING SYSTEMS INFORMATION

REFER TO ELECTRICAL ENGINEERING DRAWINGS FOR ELECTRICAL LAYOUT AND SYSTEM INFORMATION

MAR 6 2012



3
 1/4" = 1'
 1/8" HIGH SCALE
 24x36
 1/8" HIGH SCALE

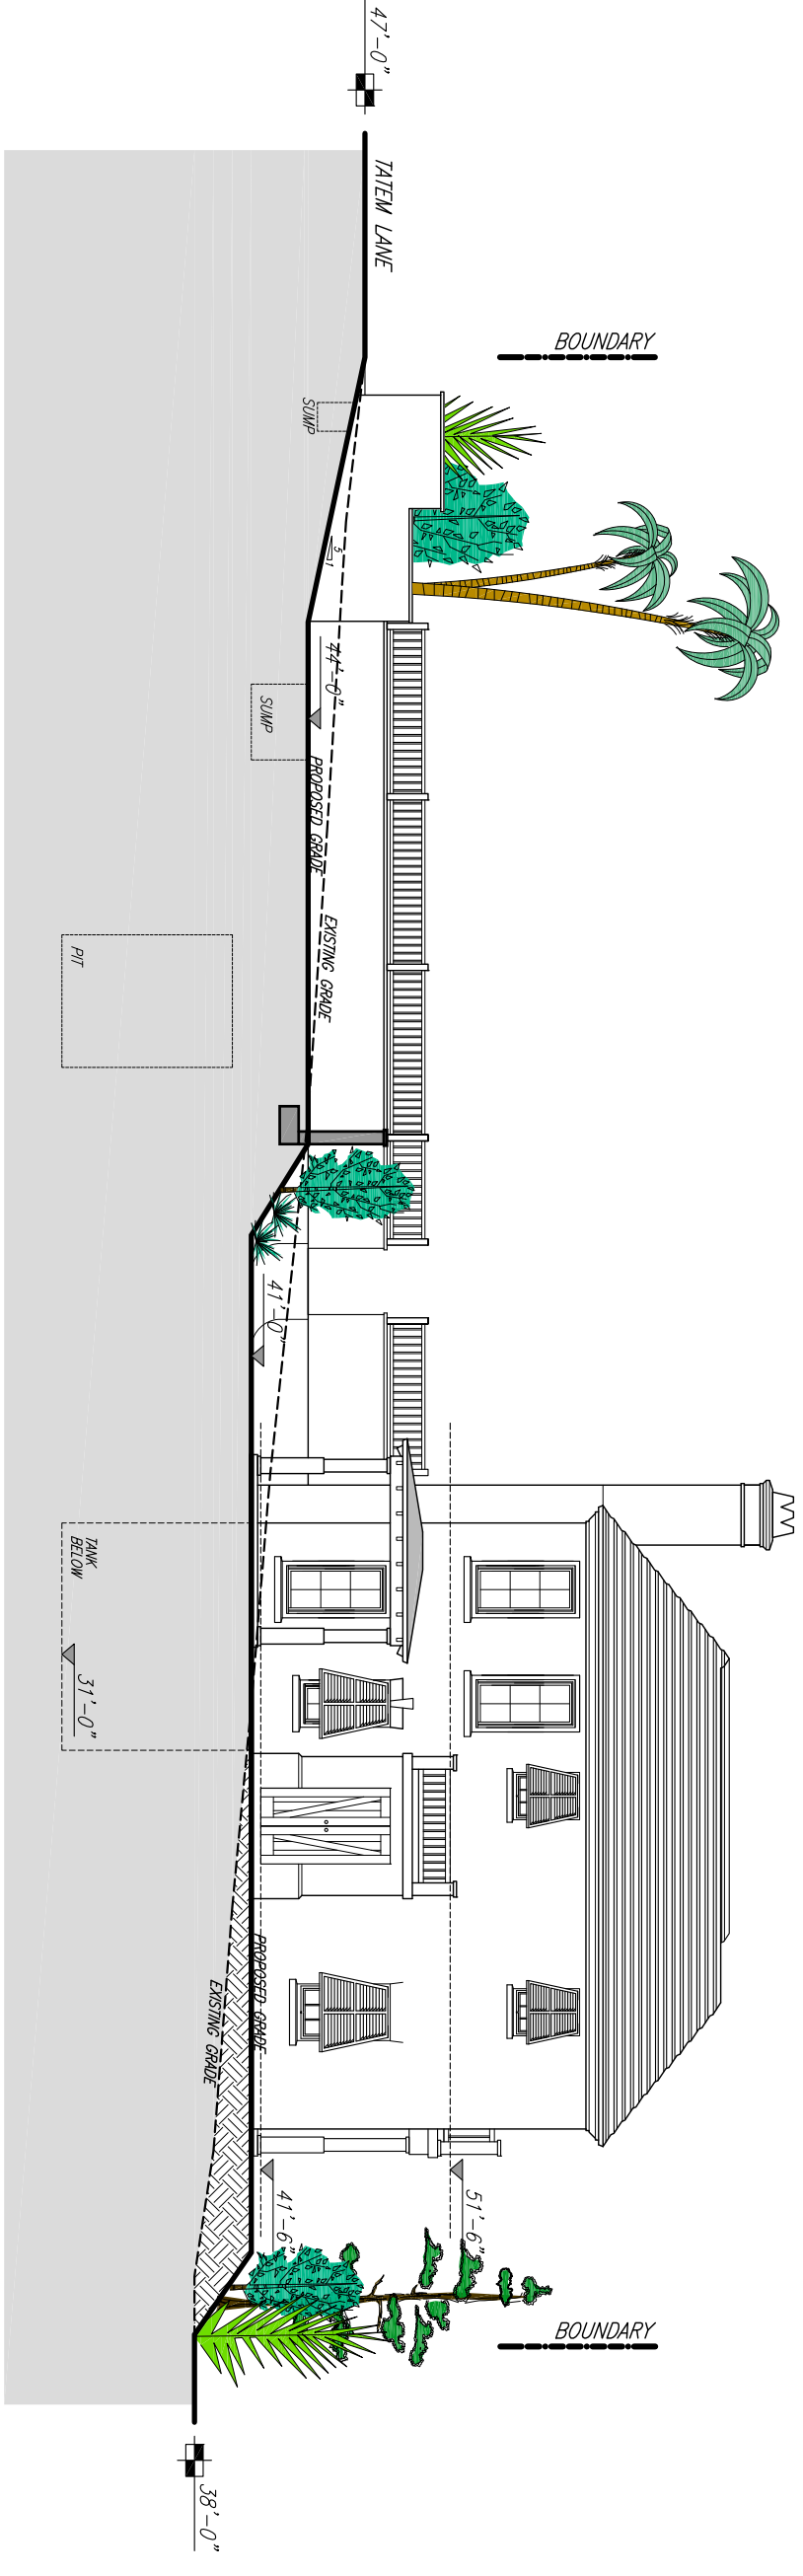

4
 1/4" = 1'
 1/8" HIGH SCALE
 24x36
 1/8" HIGH SCALE

REVISIONS

N/A
HIDEAWAY TRUST
LOT 16 & 17 TATEM LN
PEMBROKE PARISH
BERMUDA

ISSUED BY: /AM / SV
 APPR: S/D/S 02/030
 DATE: DEC 2011
 SCALE: AS NOTED