




1 LOCATION PLAN NTS

- PLANTING**
- EXISTING TREE TO BE REMOVED
 - OLIVEWOOD - 3 GAL TOTAL 34 (AS SHOWN)
 - OLEANDER - 1 GAL TOTAL 166 @ 3' C/C
 - PRIVET - 1 GAL TOTAL 216 @ 3' C/C
 - CALLAPHYLUM - 10 GAL TOTAL 7 (AS SHOWN)
 - BOA CEDAR - 10 GAL TOTAL 7 (AS SHOWN)
 - BOA PALMETTO - 10 GAL TOTAL 10 (AS SHOWN)
 - BOTTLE BRUSH - 3 GAL TOTAL 12 (AS SHOWN)
 - DATE PALM - 10 GAL TOTAL 2 (AS SHOWN)
 - BOA SNOWBERRY - 1 GAL TOTAL 38 (AS SHOWN)

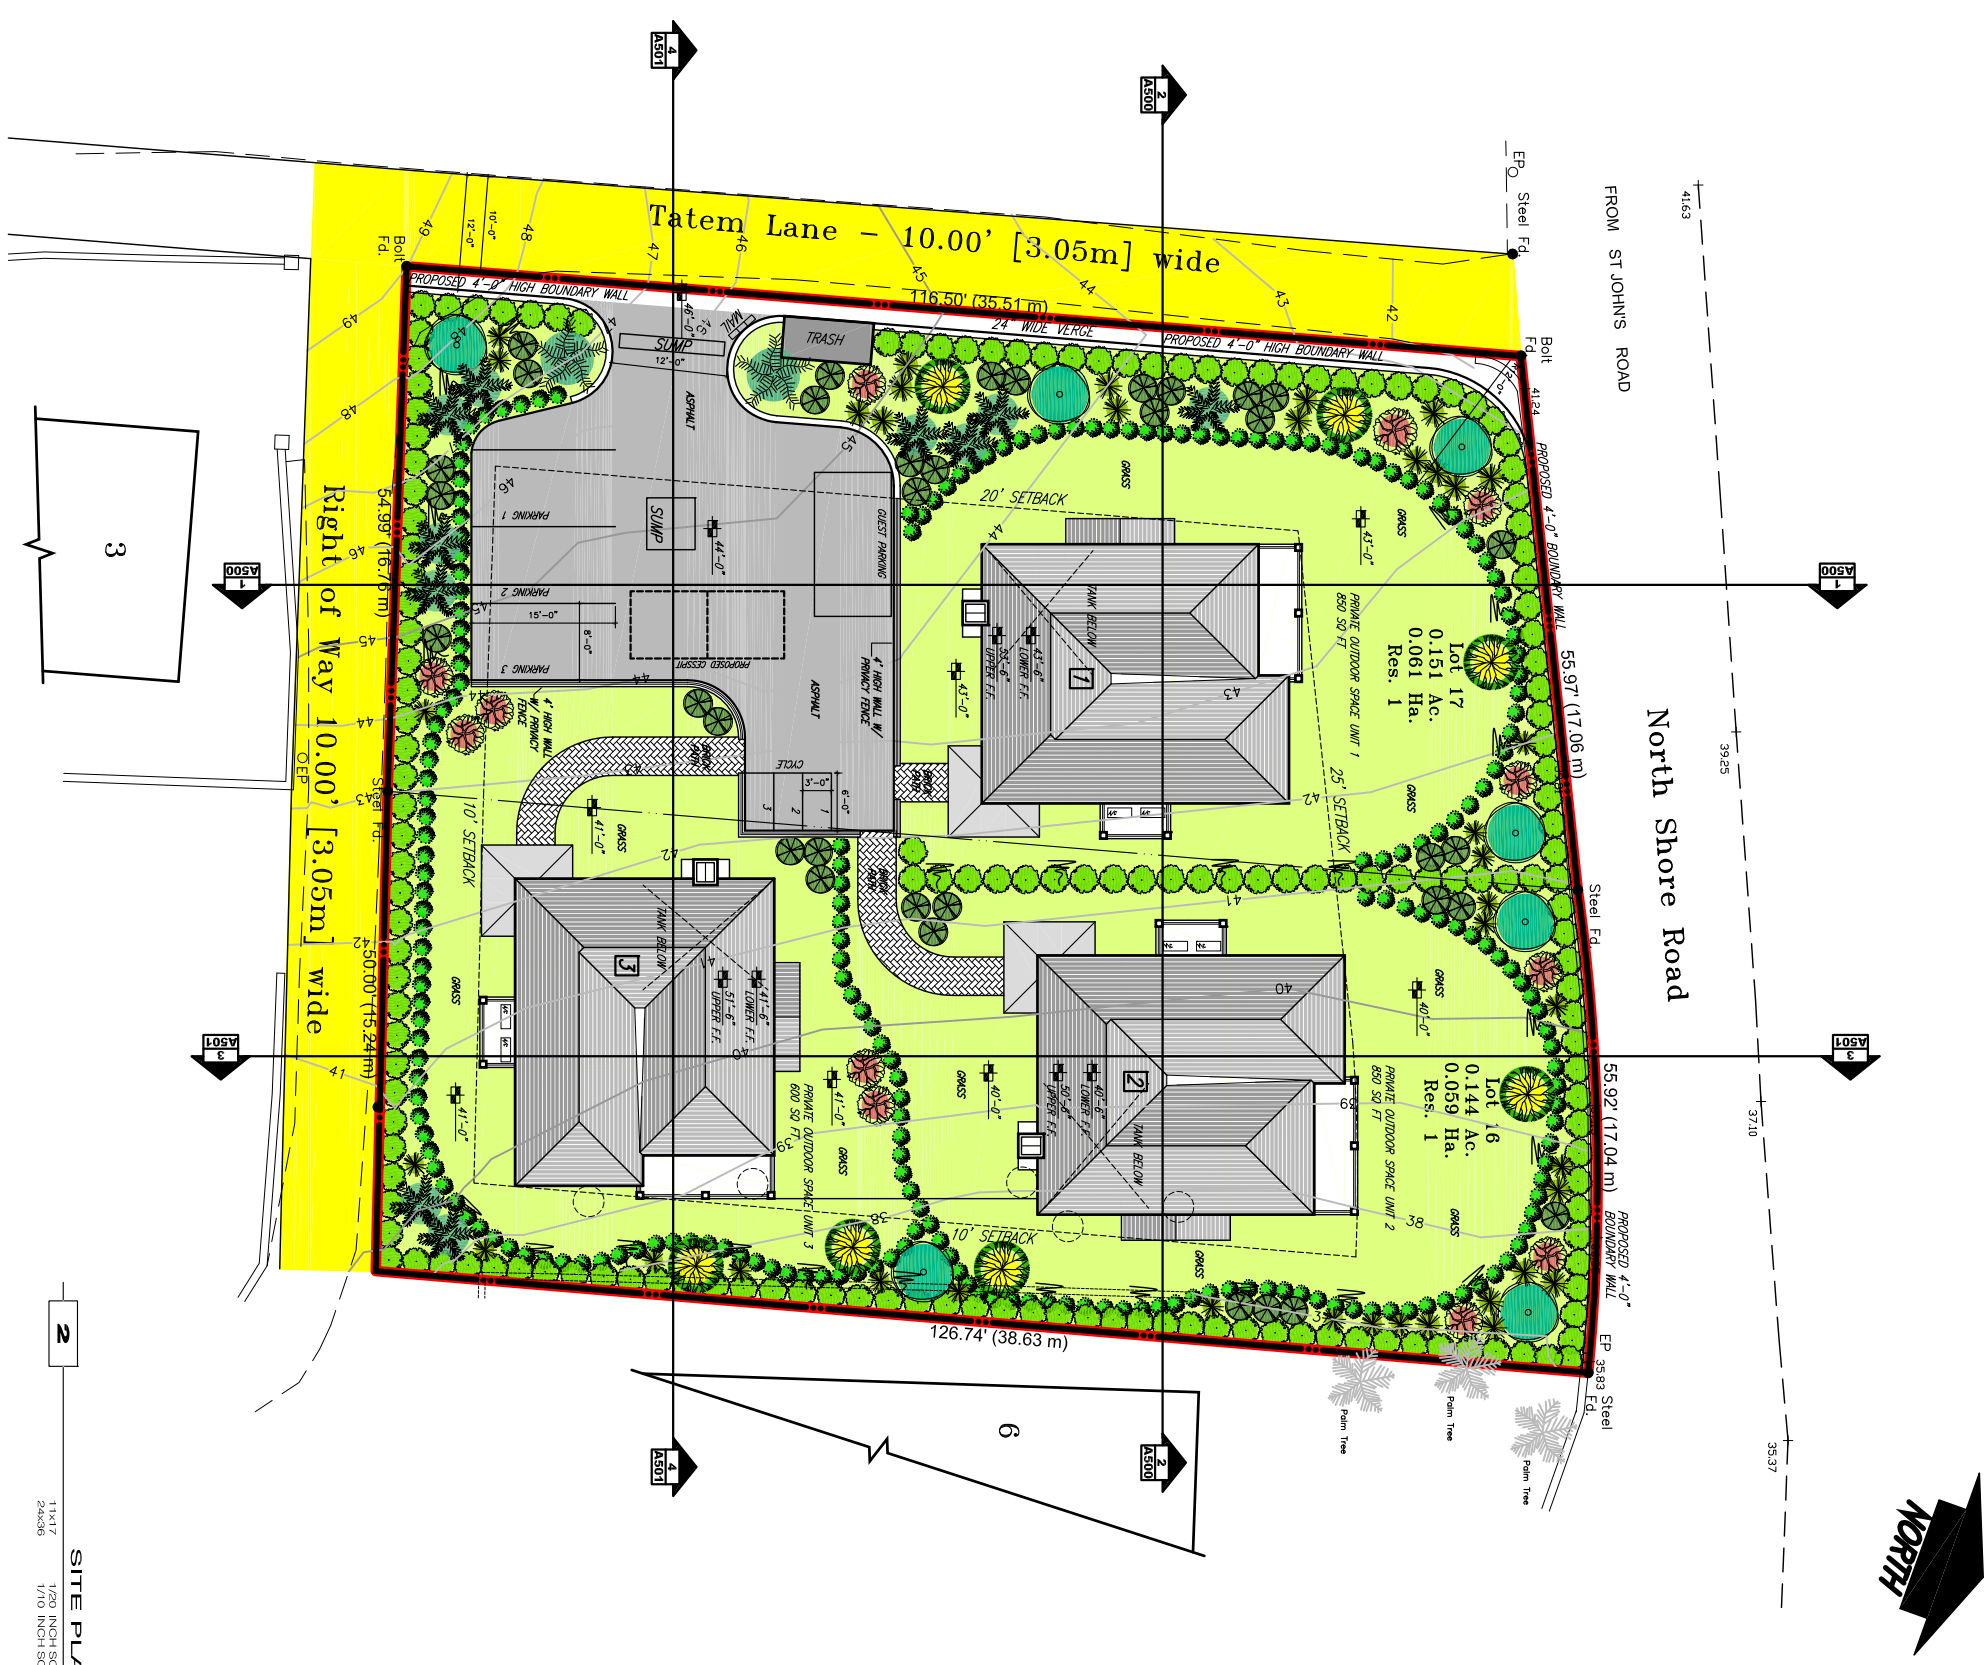

2 SITE PLAN 1/10 INCH SCALE



CTPX

GENERAL NOTES
 DO NOT SCALE DRAWINGS
 ANY MISSING OR UNCLEAR DIMENSIONS TO BE REPORTED TO CTPX FOR CLARIFICATION
 REFER TO STRUCTURAL ENGINEER NOTES FOR ALL DRAWINGS
 REFER TO MECHANICAL ENGINEERING PLANS FOR PLUMBING AND AIR CONDITIONING SYSTEMS INFORMATION
 REFER TO ELECTRICAL ENGINEERING DRAWINGS FOR ELECTRICAL LAYOUT AND SYSTEM INFORMATION

MAR 6 2012

-ZONING	RESIDENTIAL 1
-LOT SIZE	12,851 SQ FT
-SITE COVERAGE	
EXISTING	0 SQ FT
PROPOSED	2,985 SQ FT
TOTAL	2,985 SQ FT
EXIST HARD SURF.	0 SQ FT
PROP HARD SURF.	5,355 SQ FT
-SITE COVERAGE PERCENTAGE	
EXISTING	0%
PROPOSED	23.2%
TOTAL	23.2%
EXIST HARD SURF.	0%
PROP HARD SURF.	41.6%
-FLOOR AREA [UNIT 1]	
EXISTING	0 SQ FT
PROPOSED	1,430 SQ FT
TOTAL	1,430 SQ FT
-FLOOR AREA [UNIT 2]	
EXISTING	0 SQ FT
PROPOSED	1,430 SQ FT
TOTAL	1,430 SQ FT
-FLOOR AREA [UNIT 3]	
EXISTING	0 SQ FT
PROPOSED	1,430 SQ FT
TOTAL	1,430 SQ FT
-TANK CAPACITY	
EXISTING	0 GAL
PROPOSED	30,000 GAL
TOTAL	30,000 GAL
-NUMBER OF CESSPITS	
EXISTING	0
PROPOSED	?
TOTAL	?
-AREA OF ROOF	
EXISTING	0 SQ FT
PROPOSED	2,535 SQ FT
TOTAL	2,535 SQ FT

REVISIONS
 N/A

HIDEAWAY TRUST
LOT 16 & 17 TATEM LN
BERMBOKE PARISH
BERMUDA

ISSUED BY: AAM / SVV
 DATE: DEC 2011
 SCALE: AS NOTED

A 100